



PHILIPPINE HEART CENTER
East Avenue, Quezon City

SUPPLEMENTAL BID BULLETIN No. 027-2021

SUBJECT : Revisions in the Bidding Documents

PROJECT/S : 2 units Patient Call System/Call Lights - ITB No. 028.21

 
To ensure that the transactions are comparatively advantageous to the interests of the PHC, the originally pre-issued bidding documents as mentioned above, revisions are hereby introduced:


Item No./ Page No.	PHC – Technical Specifications FROM	Clarifications/Modifications (Should be read as) TO
		Additional Requirements:
		1. Delivery Period – 60 calendar days
		2. Preventive Maintenance every 6 months for 5 years
		3. Warranty – 5 years on parts and labor
		4. Availability of spare parts in the market for 5 years
		5. Floor Plan for the layout of Nurse Call System at 2 nd Flr & 4 th Flr.

This Supplemental Bid Bulletin is hereby issued to modify the original parameters as stated therein. All other requirements previously stated on the bid documents must be complied.

Please be guided accordingly.

Approved. Done this 28th day of June 2021, BAC Office.



MARIETTA A. VELASCO, RN, MAN.
Chairman, BAC for Pharma Supplies and Med Equipment

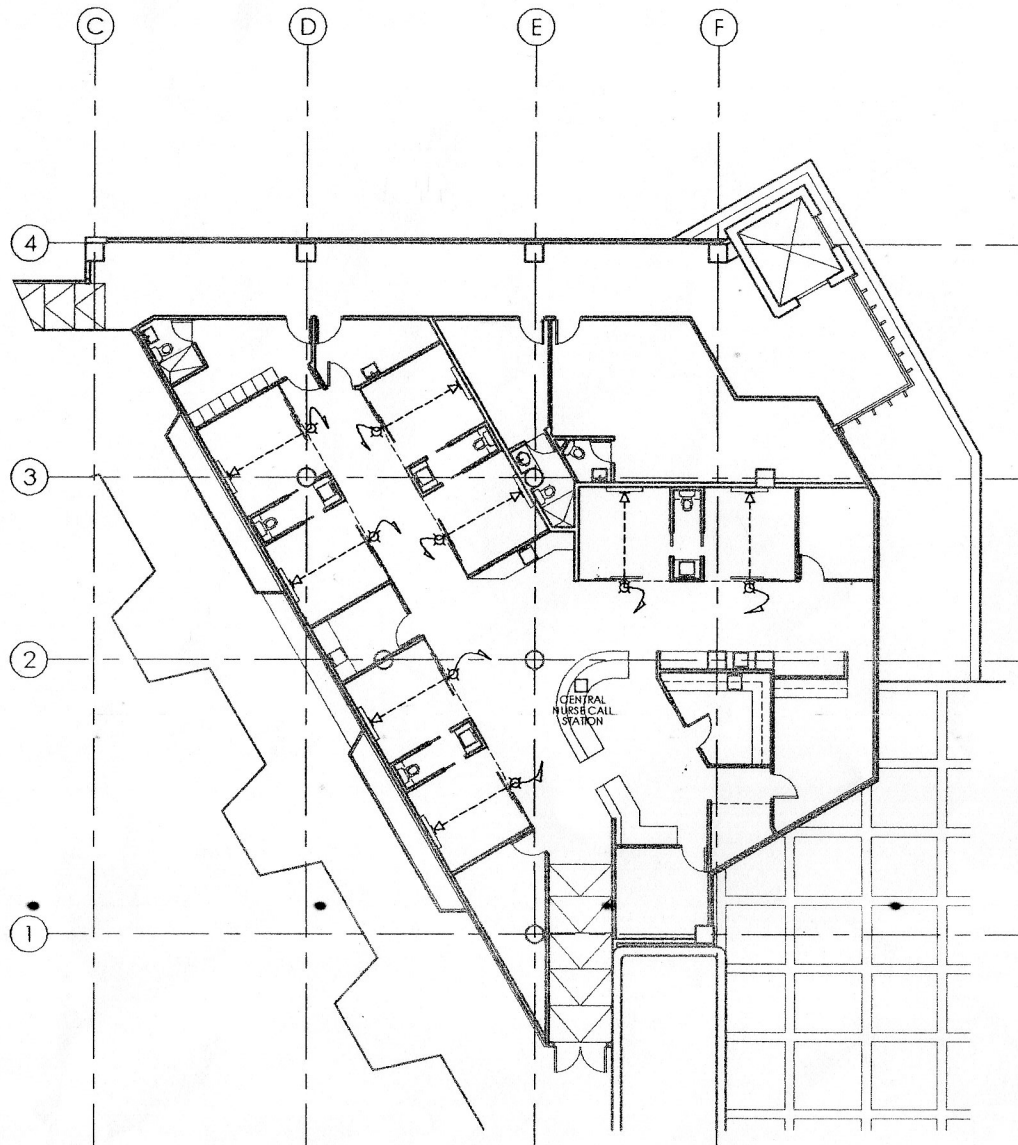

2/F NURSE CALL SYSTEM LAYOUT

SCALE

1:100 MTS.

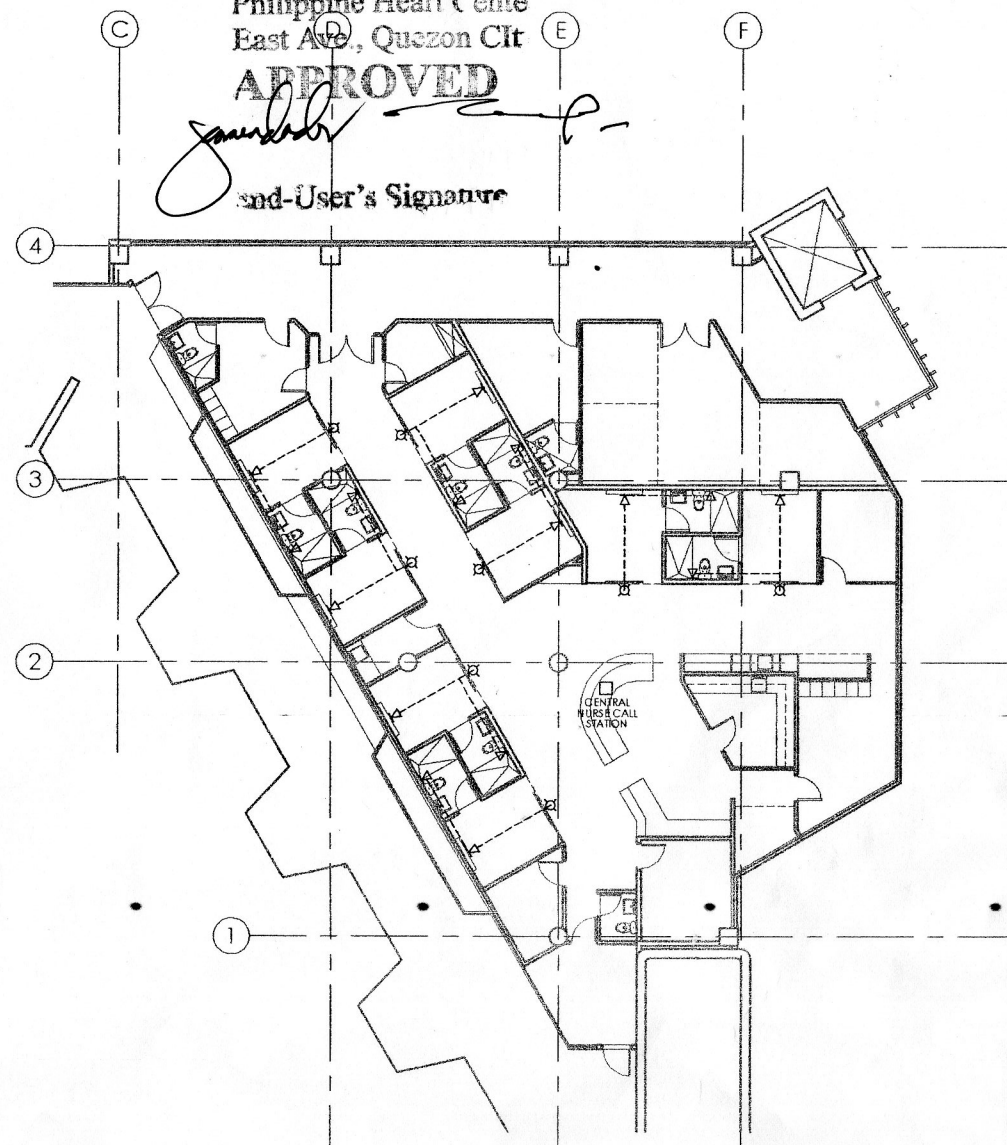

4/F NURSE CALL SYSTEM LAYOUT

SCALE 1:100 MTS.

AREA = ±445 m²

Philippine Heart Center
East Ave., Quezon City
APPROVED
[Signature]
End-User's Signature

ENGINEER:

SEAL

ENDORING APPROVAL:

[Signature]
ENGR. DIONISIO H. EOY, JR.
OIC - Engineering & Maintenance Division

PROJECT & LOCATION

**PROPOSED ARCHITECTURAL FIT-OUT FOR THE
VERTICAL EXPANSION OF HOSPITAL BUILDING @
2ND - 5TH FLOOR ABOVE NEW EMERGENCY ROOM
TO INCLUDE PROVISION OF GROUND FLOOR NEW LIFT & LOBBY**

FINAL APPROVAL:

JOEL M. ABANILLA, MD
Executive Director
Philippine Heart Center

SHEET CONTENTS:

SECOND & FOURTH FLOOR
NURSE CALL SYSTEM LAYOUT

REVISIONS:

SHEET NO.

E 6

Date: 11/25/2020